
 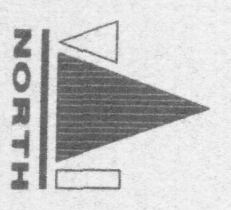


THIRD FLOOR PLAN

SCALE: 1/8" = 1'-0"



ARCHITECTURAL NOTES

- 1) CMU Infill. Patch around opening & prepare cmu surface to match adjacent.
- 2) S1, stud & gyp bd infill. Patch around opening & prepare surface to match adjacent.
- 3) Patch around opening & prepare surface to match adjacent.

GENERAL NOTES

- All dimensions are shown to face of stud, unless noted otherwise.
- New partitions to extend min. 6" above ceiling, unless noted otherwise.
- See Structural, Plumbing, HVAC, & Electrical Plans for other work.
- See Reflected Ceiling Plan for soffits & bulkheads this floor.

THIRD FLOOR PLAN

BAIK COUNTY BUILDINGS
BARABOO, WI

VERBICHER
ARCHITECTS

400 VIKING DR., P.O. BOX 379, REEDSBURG, WI 53959, 800-524-6468
DRAFTSMAN: [] CHECKED: [] DATE: 11/17/95 SCALE: As Noted

NO.	DATE	REVISIONS	REMARKS

FIELD BOOK FILE NO.
JOB NO. 134625920 1004
SHEET 9 of 76 DWG. NO. A4